
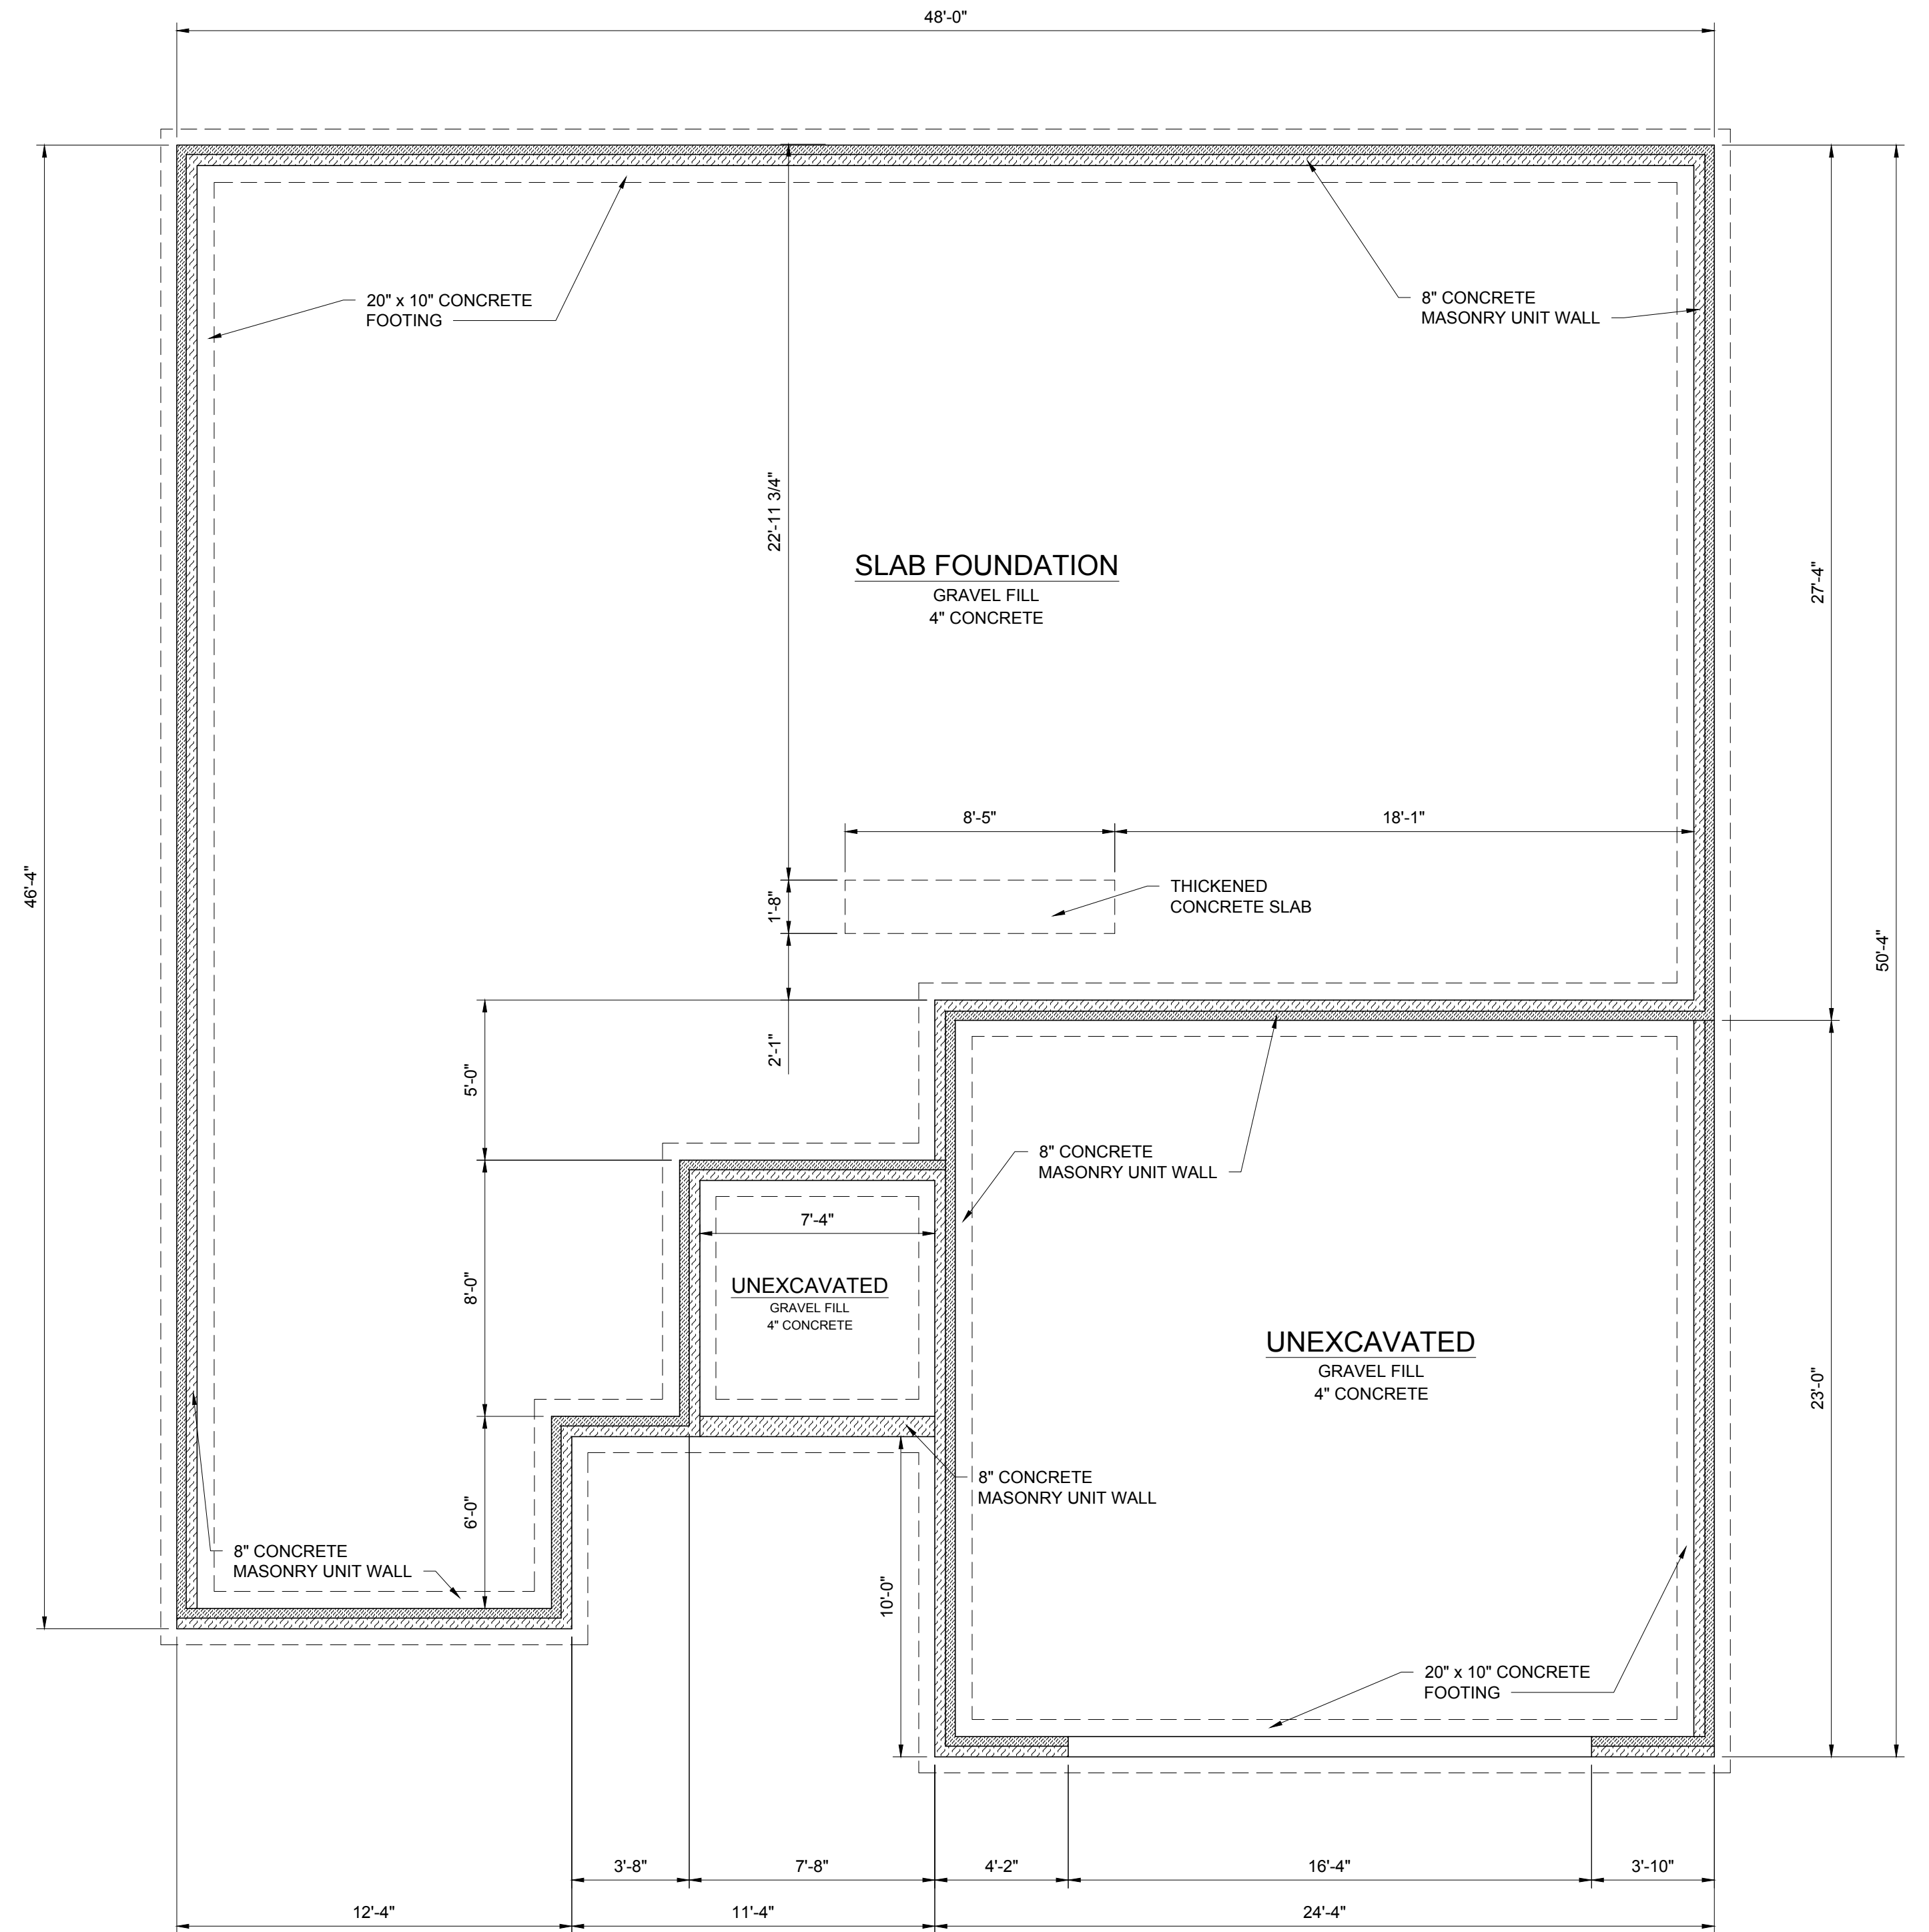


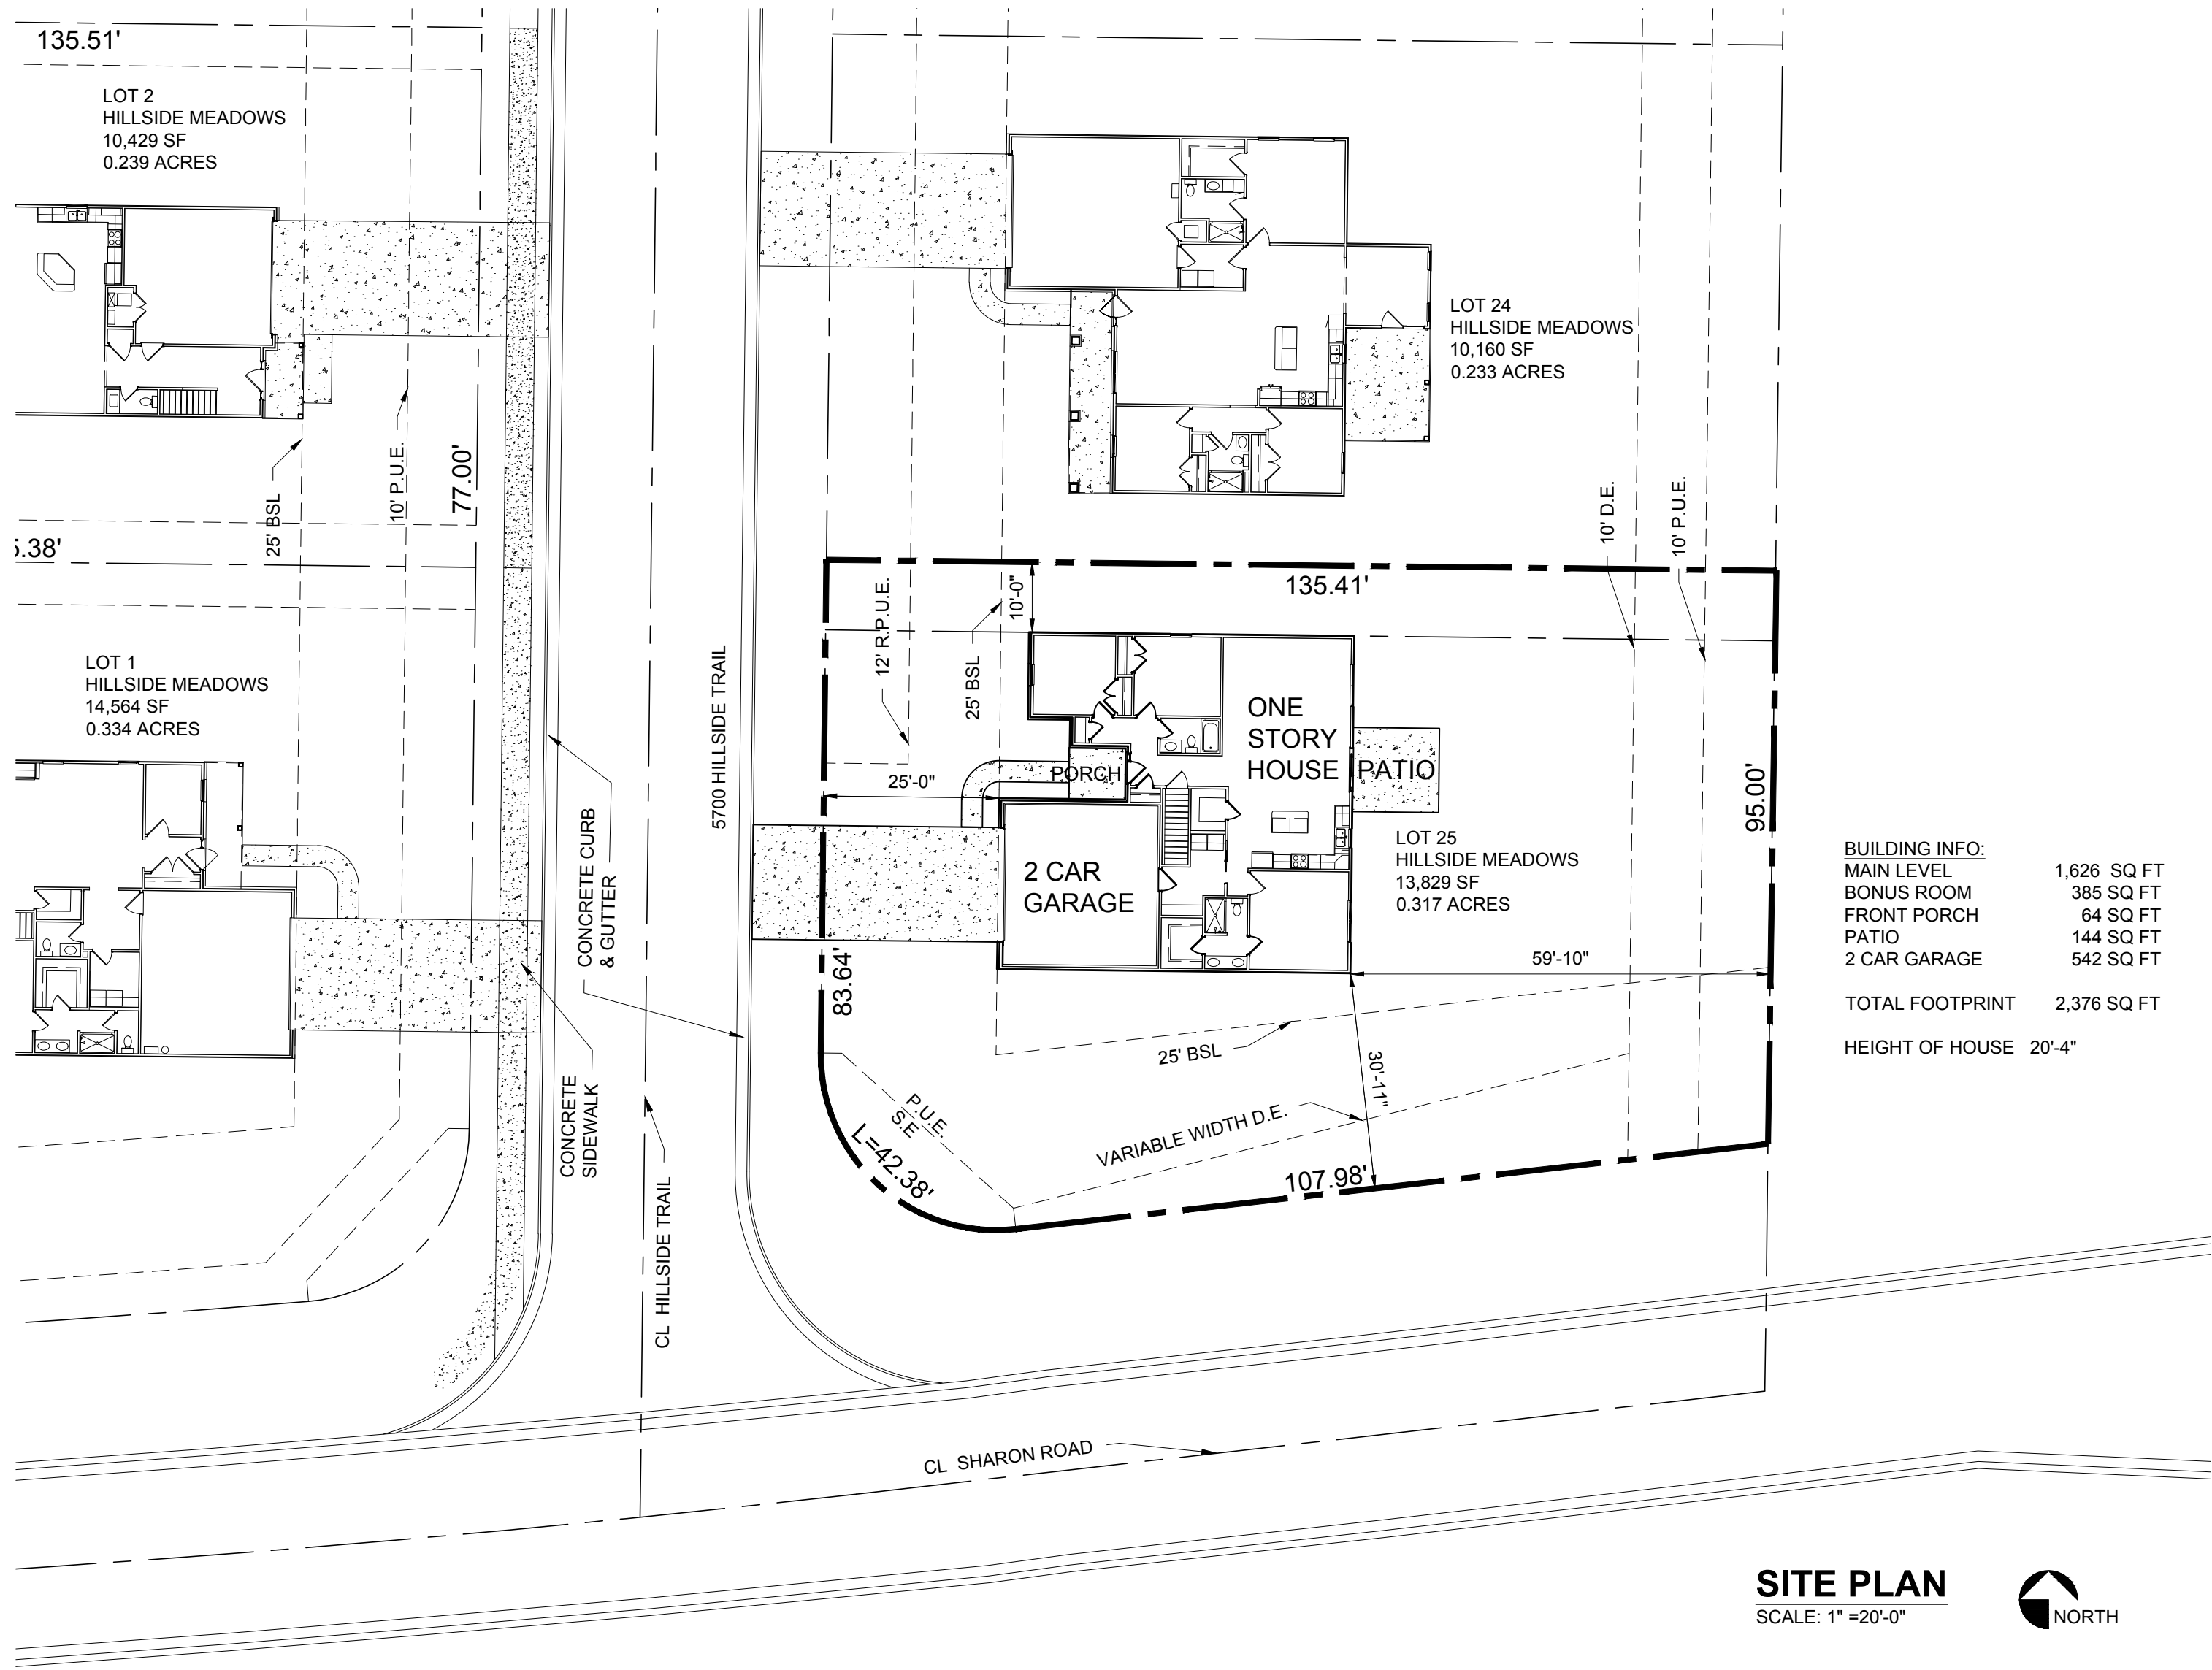

FOUNDATION PLAN
SCALE: 1/4" = 1'-0"

GENERAL NOTES:

MATERIALS KEY:

- POURED CONCRETE WALLS
- CONCRETE MASONRY UNIT WALLS
- WOOD FRAME WALLS

CONSTRUCTION NOTES:

- SLAB ON GRADE
- EXTERIOR DIMENSIONS TO THE FACE OF CMU WALLS
- 20"x10" CONCRETE FOOTINGS (CONTRACTOR TO VERIFY PER BUILDING CODE)

HM LOT 25 SPEC
HILLSIDE MEADOW - LOT 25
5700 HILLSIDE TRAIL, NEWBURGH, IN 47630
ASPEN PLAN



304 East State Road 68
Haubstadt, IN 47639
812-615-0137
www.reinbrechthomes.com

A0
1 of 4



CONSTRUCTION LEGEND:

MAIN LEVEL:	1,626 SQ. FT.
BONUS ROOM:	385 SQ. FT.
FRONT PORCH:	64 SQ. FT.
2 CAR GARAGE:	542 SQ. FT.

	FRAME WALLS
	STONE VENEER
	BRICK VENEER
	BRICK WAINSCOT

- SLAB ON GRADE
- 8'0" CEILING HEIGHT UNLESS OTHERWISE NOTED
- 6'8" DOORS AND CASED OPENINGS HEIGHT
- VERIFY WINDOW MANUFACTURER WITH OWNER/CONTRACTOR
- WINDOW SIZES ARE SHOWN AS INCHES
- EXTERIOR DIMENSIONS TO FACE OF SHEATHING
- EXTERIOR WALL DIMENSION IS 4" UNLESS NOTED
- INTERIOR DIMENSIONS TO FACE OF STUD WALLS
- INTERIOR WALL DIMENSION IS 3-1/2" UNLESS NOTED
- ALL WORK SHALL COMPLY WITH STATE & LOCAL BUILDING CODES & ALL OTHER APPLICABLE REGULATIONS. STATE & LOCAL CODES TAKE PRECEDENCE OVER ANY INFORMATION ON THIS PLAN.
- CONTRACTOR SHALL BE RESPONSIBLE FOR VERIFYING ALL DIMENSIONS & COORDINATING ALL REQUIRED PERMITS, INSPECTIONS, APPROVALS, ETC.







REAR ELEVATION
SCALE: 1/4" = 1'-0"



FRONT ELEVATION
SCALE: 1/4" = 1'-0"

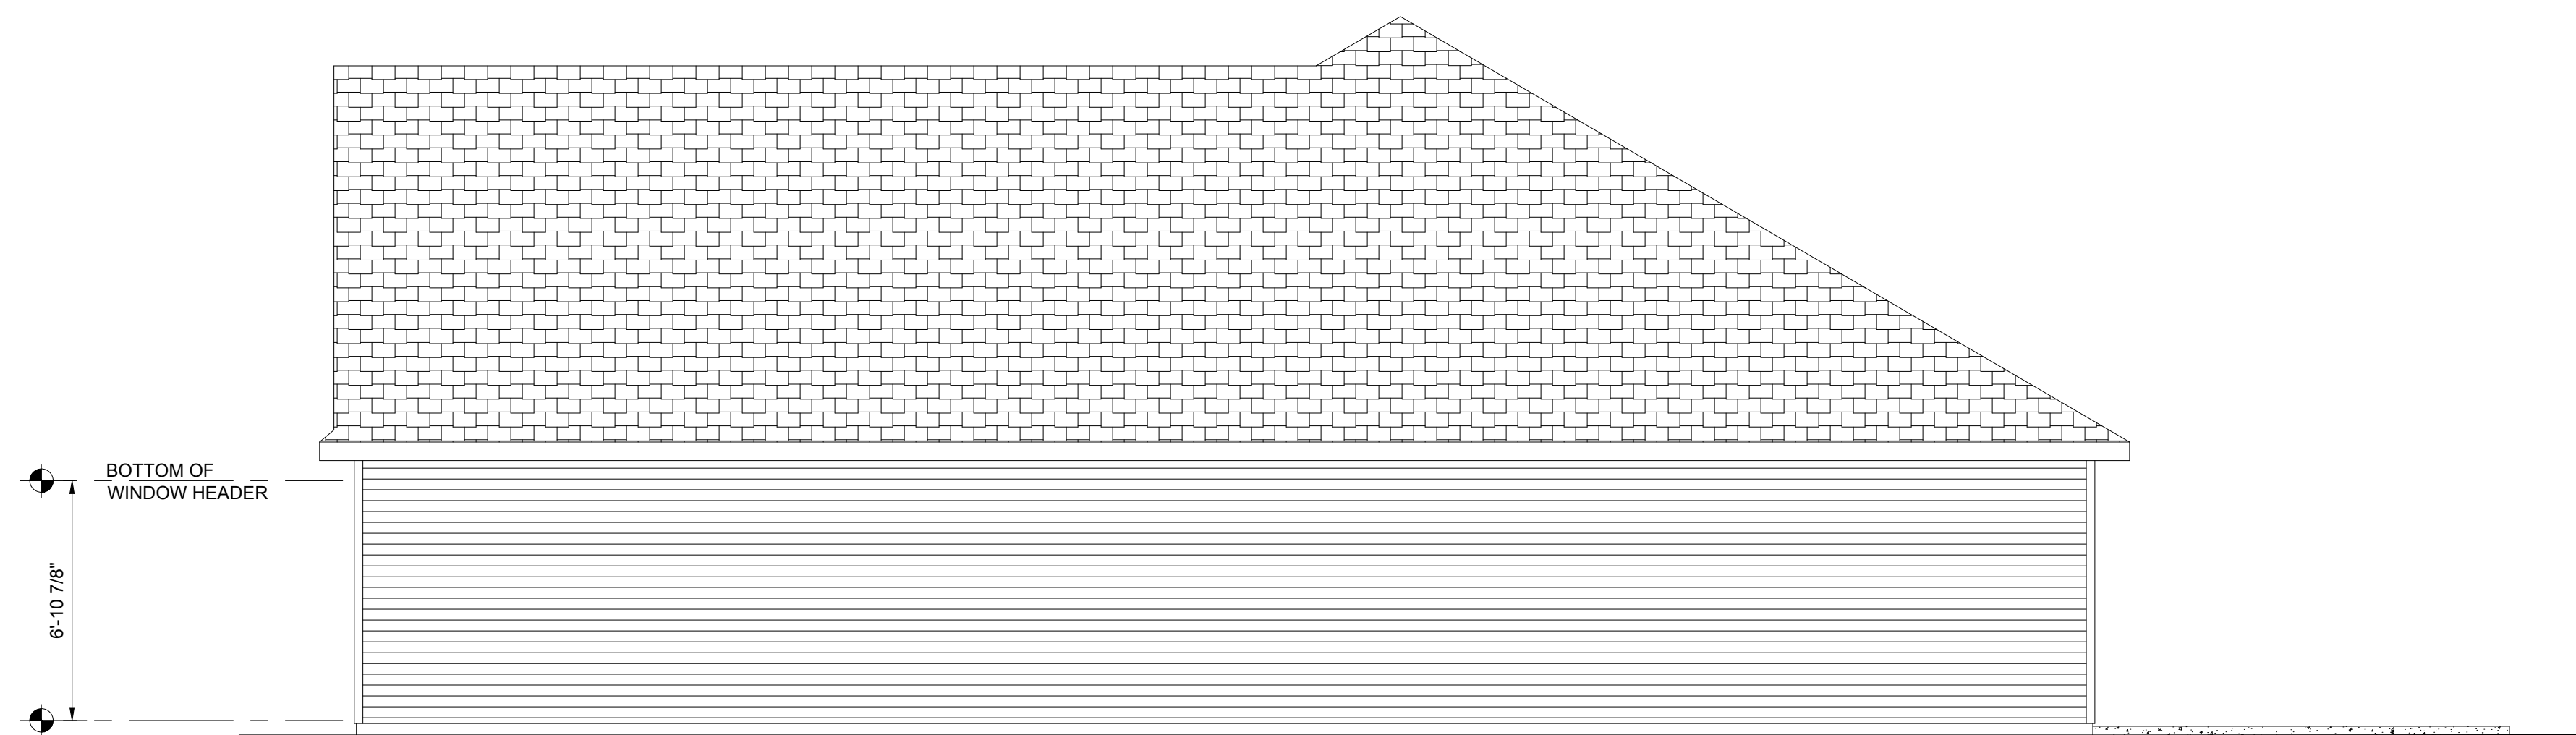

RIGHT ELEVATION
SCALE: 1/4" = 1'-0"

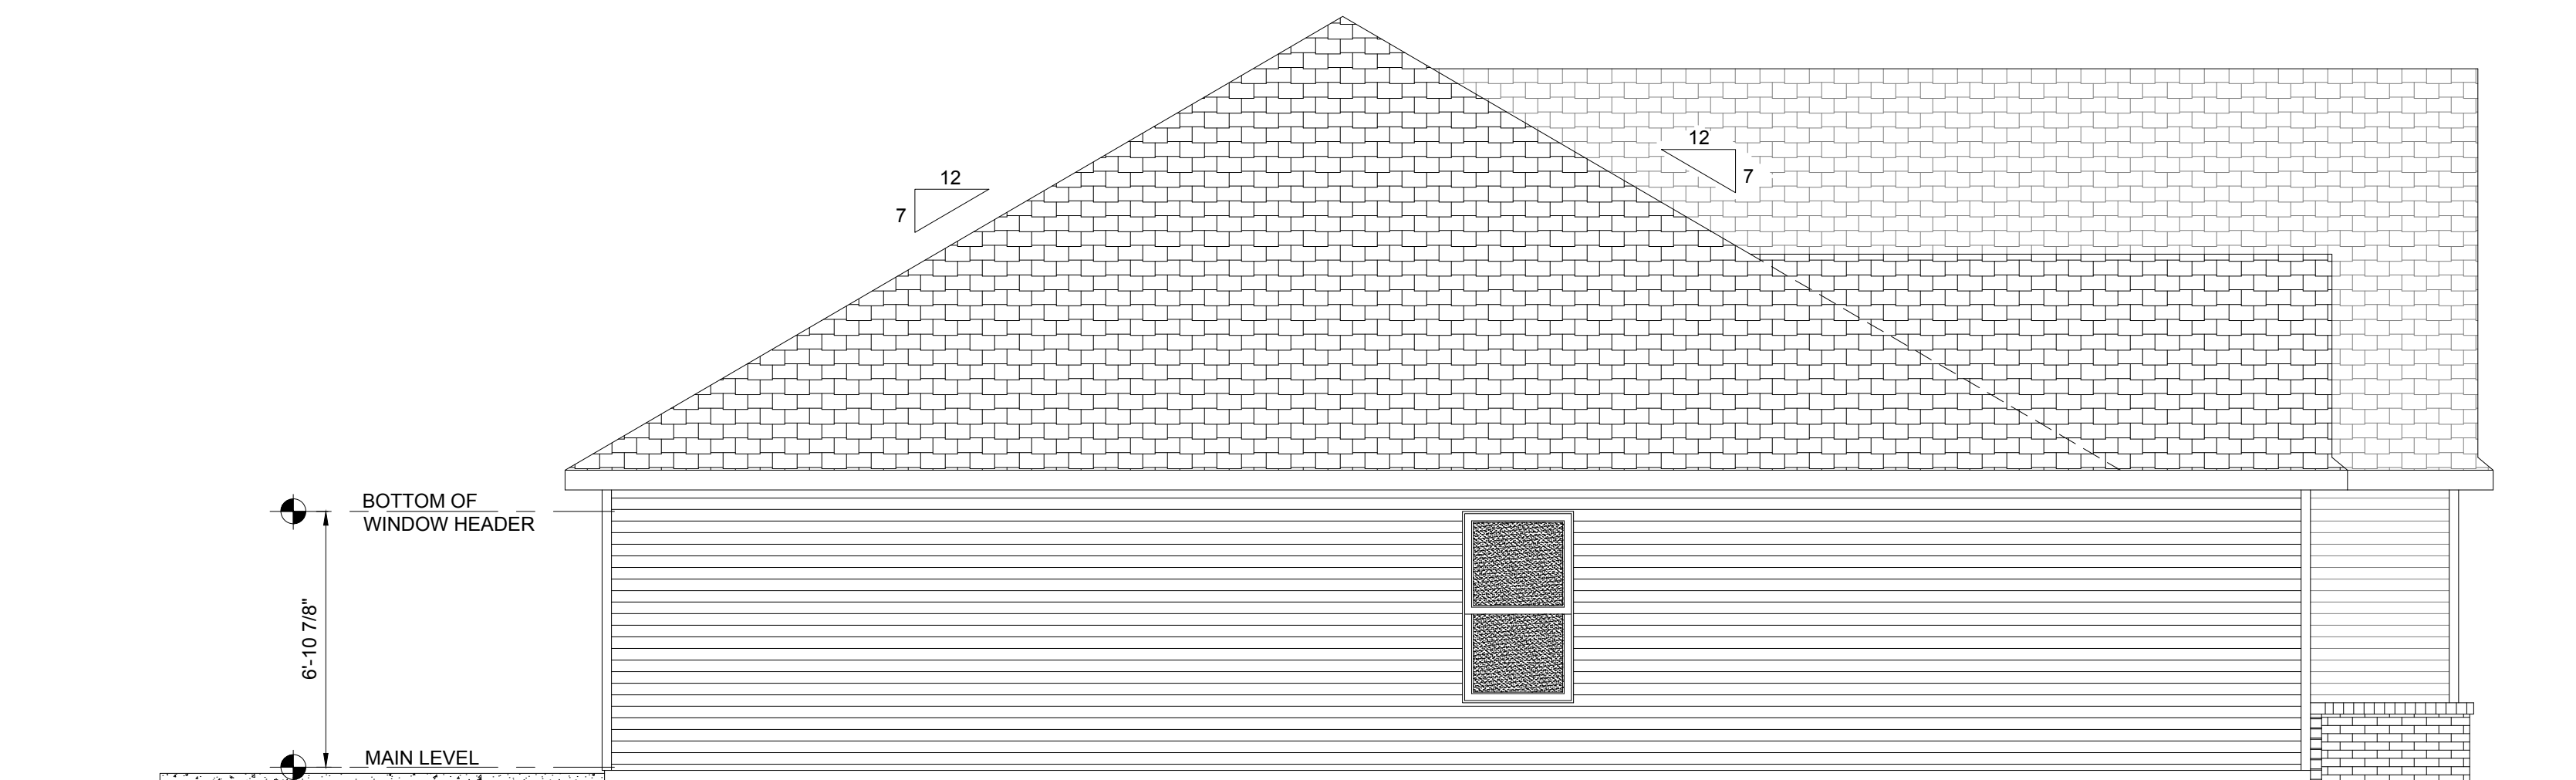


LEFT ELEVATION
SCALE: 1/4" = 1'-0"

HM LOT 25 SPEC
HILLSIDE MEADOW - LOT 25
5700 HILLSIDE TRAIL; NEWBURGH, IN 47630
ASPEN PLAN




304 East State Road 68
Haubstadt, IN 47639
812-615-0137
www.reinbrechthomes.com


A2
3 of 4

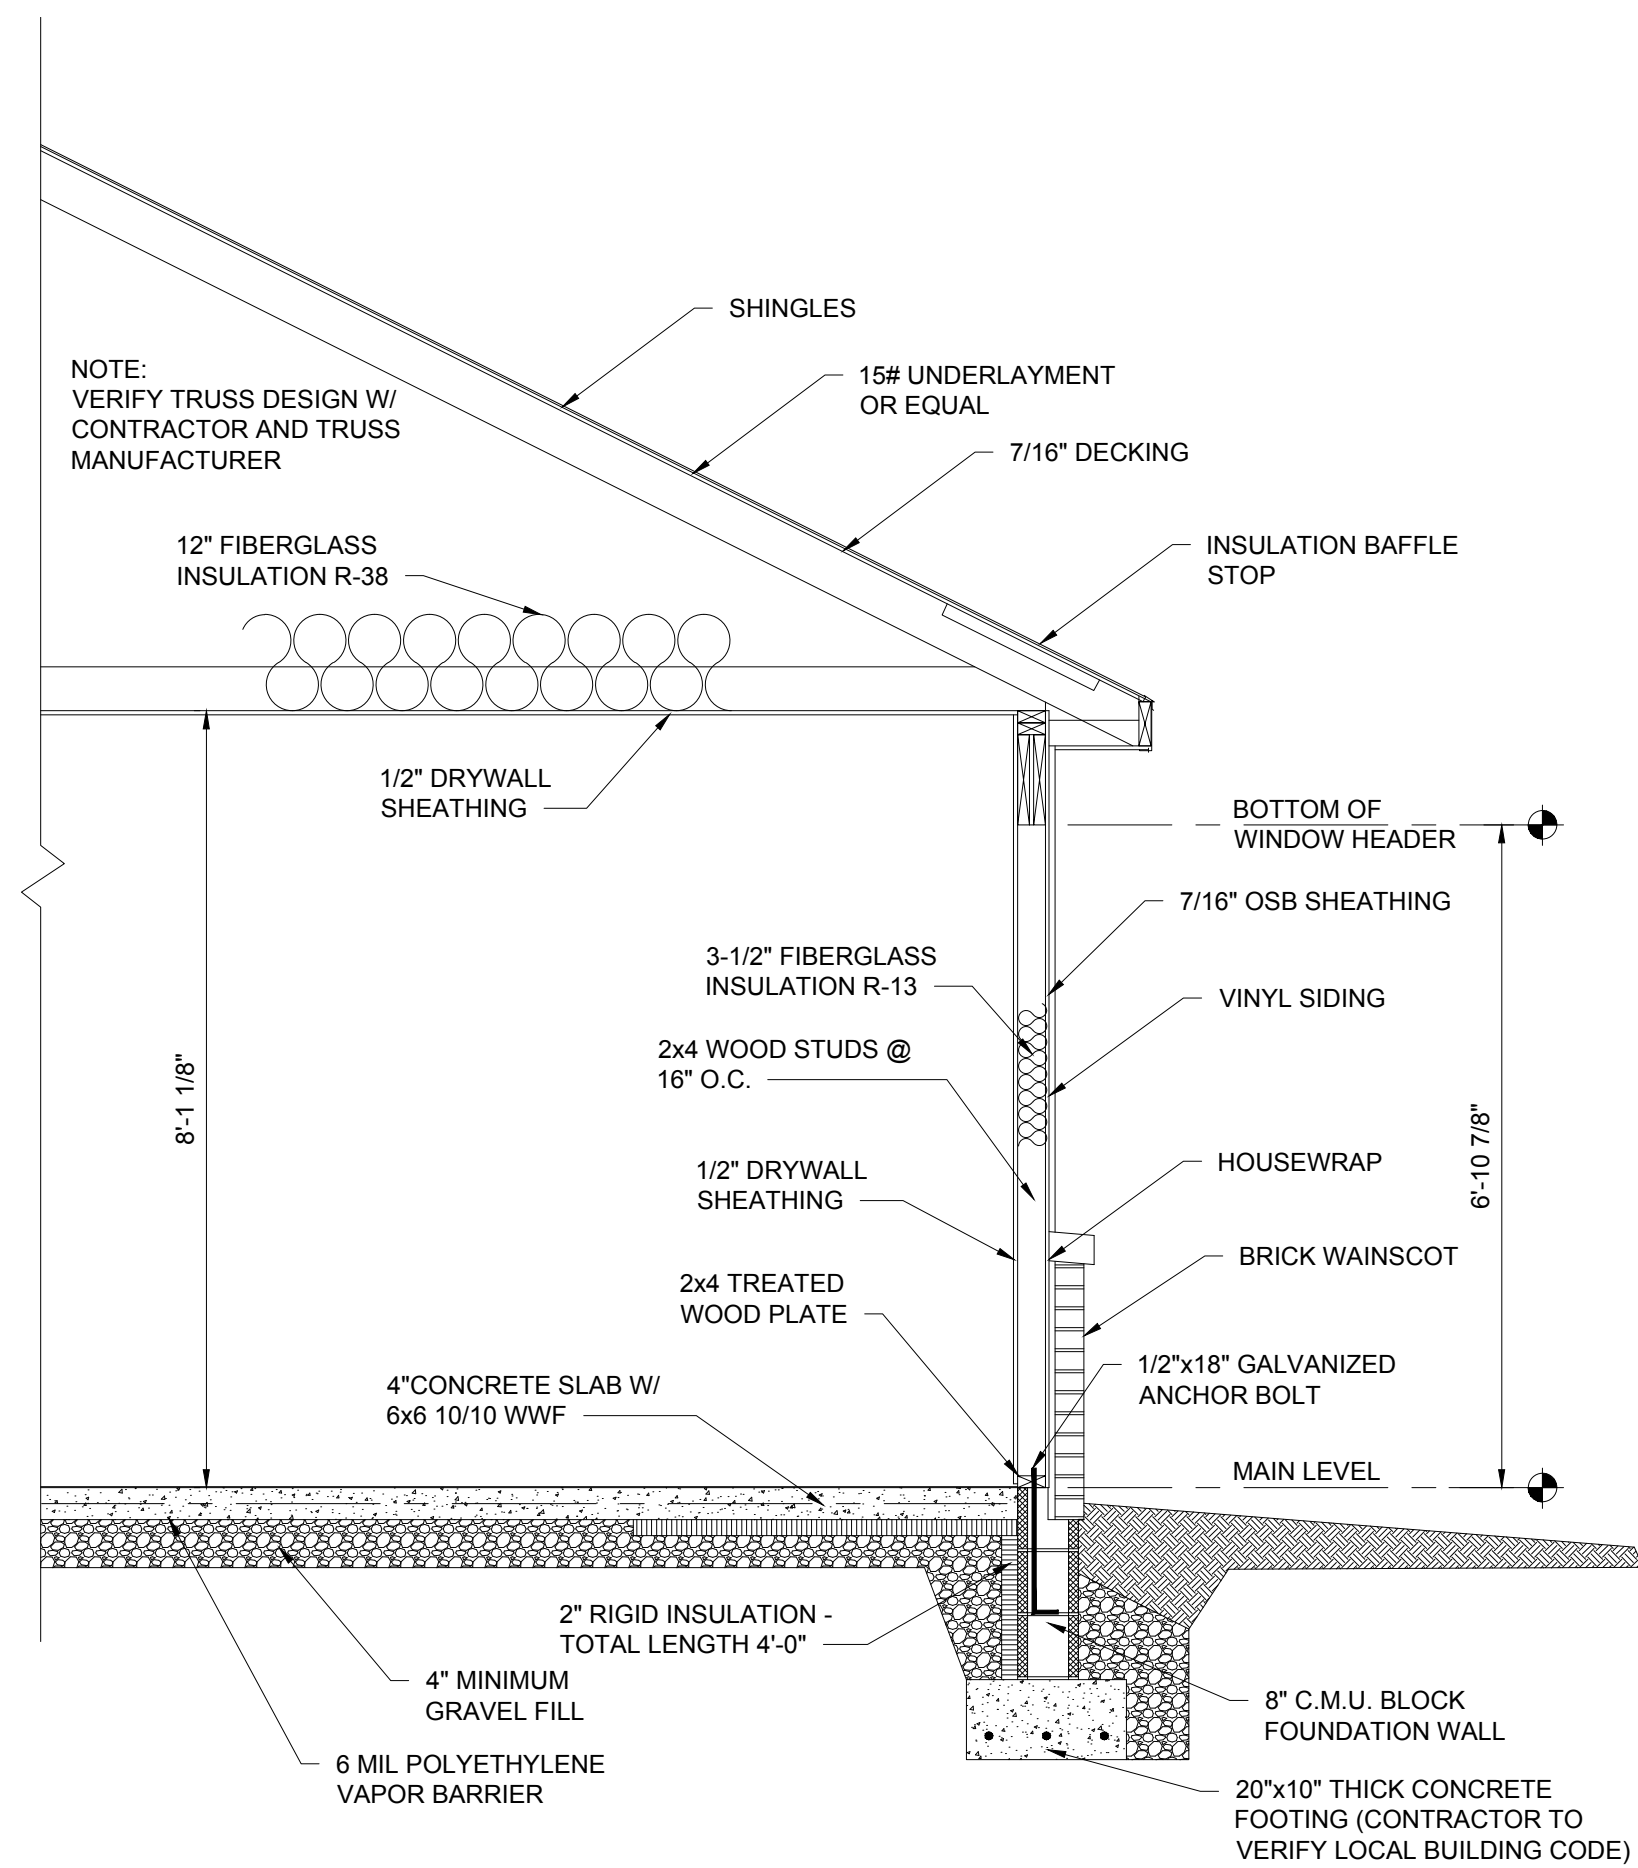

FRONT WALL SECTION
SCALE: 3/4" = 1'-0"

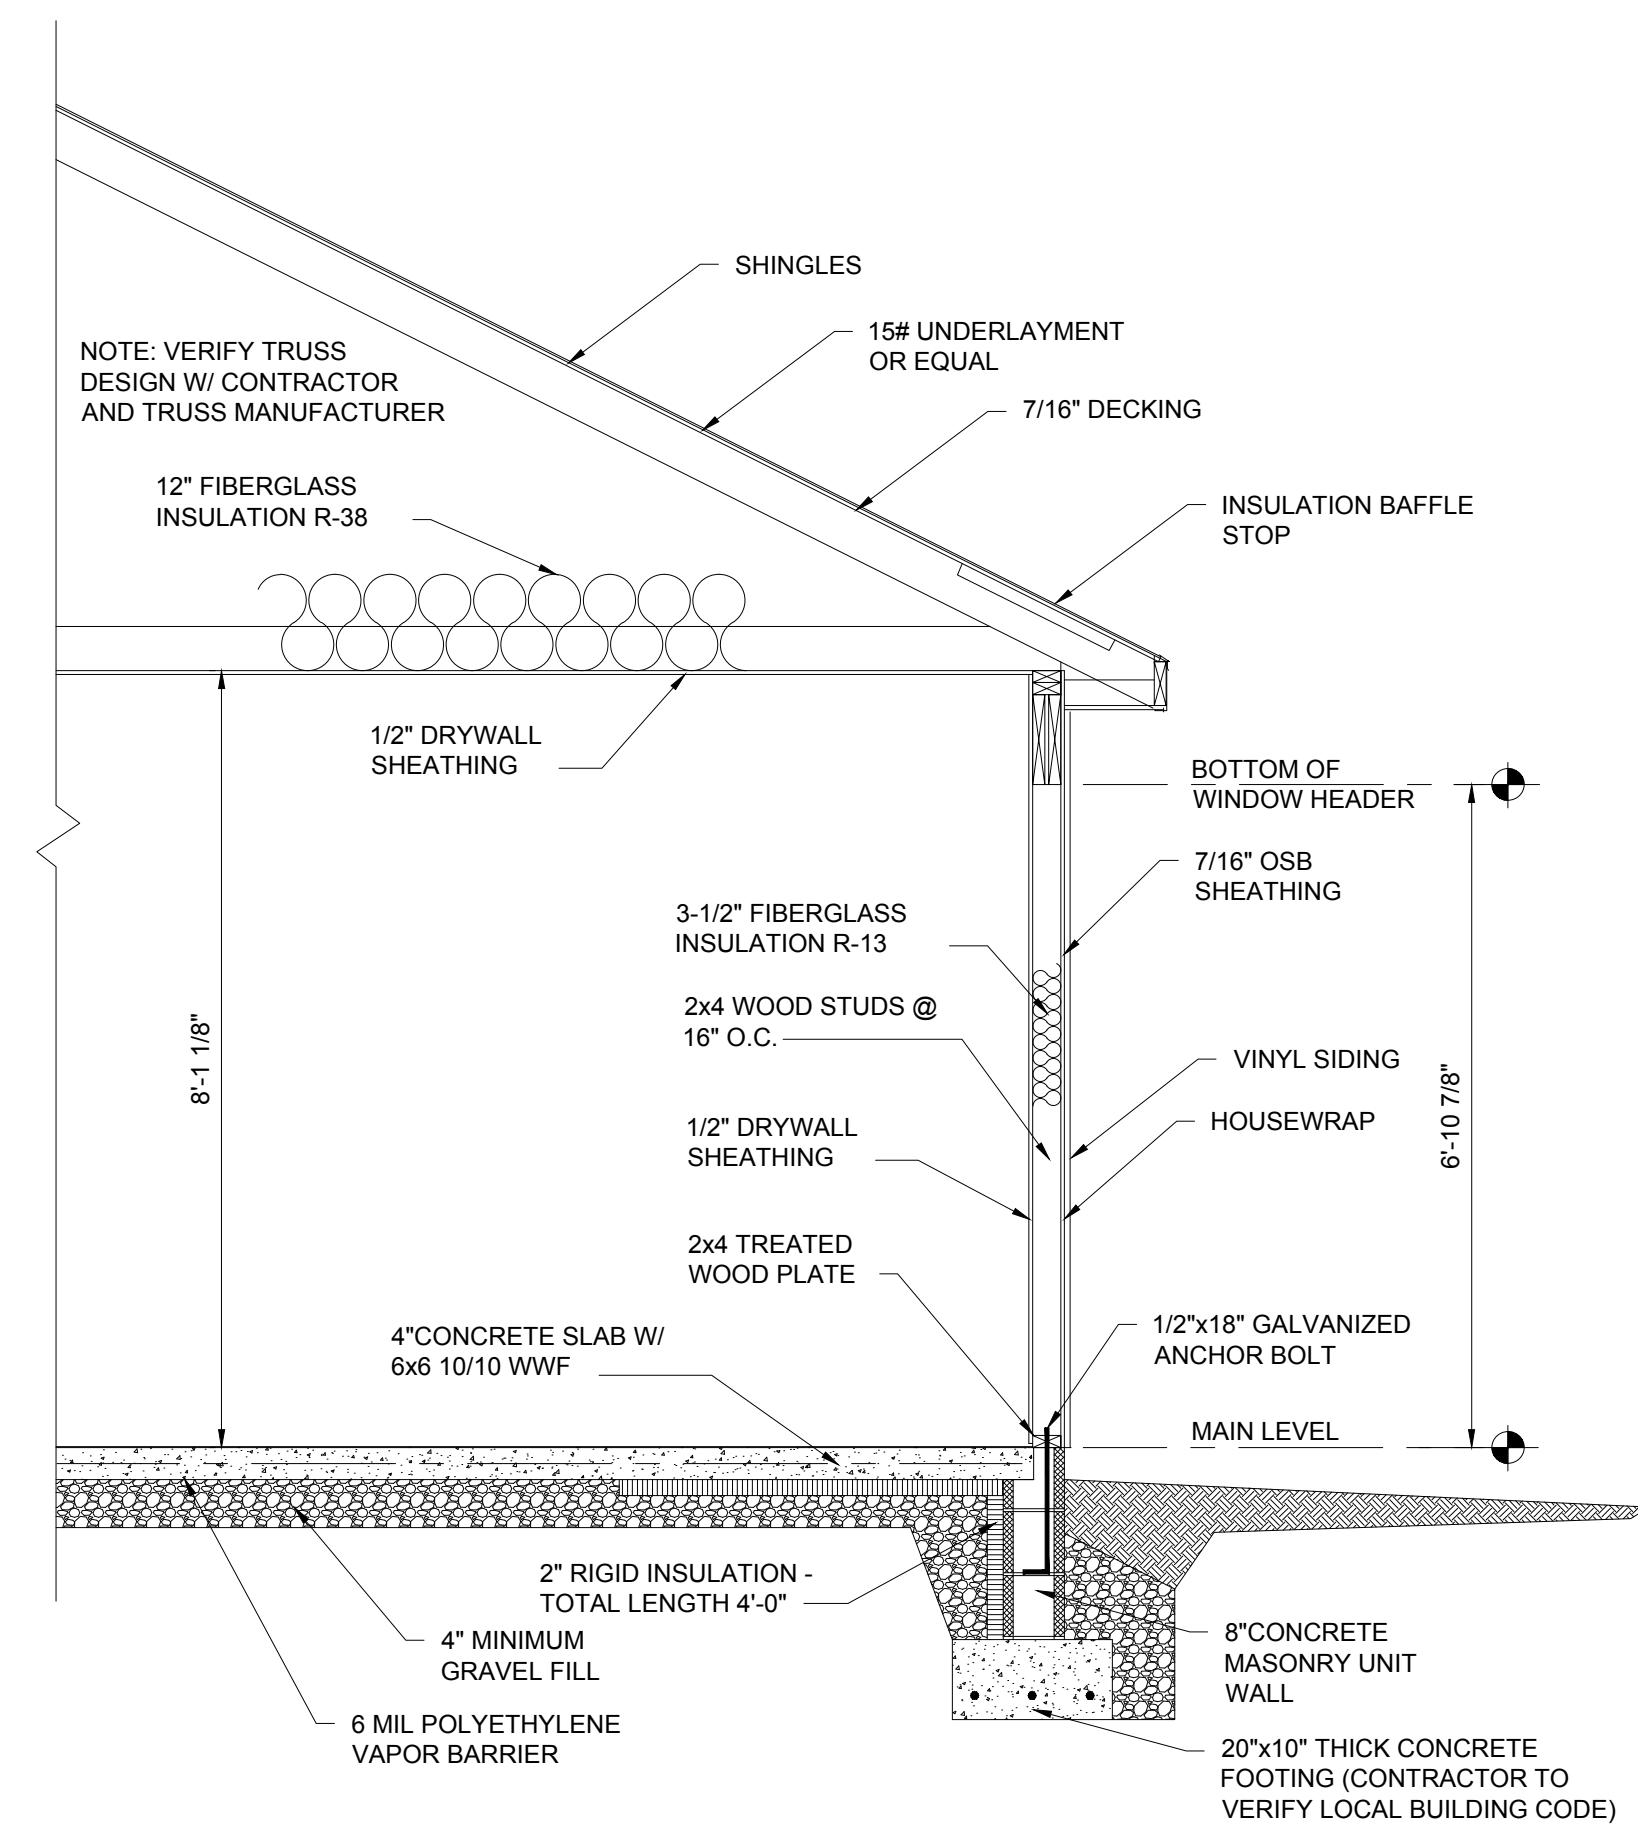

REAR & SIDE WALL SECTION
SCALE: 3/4" = 1'-0"

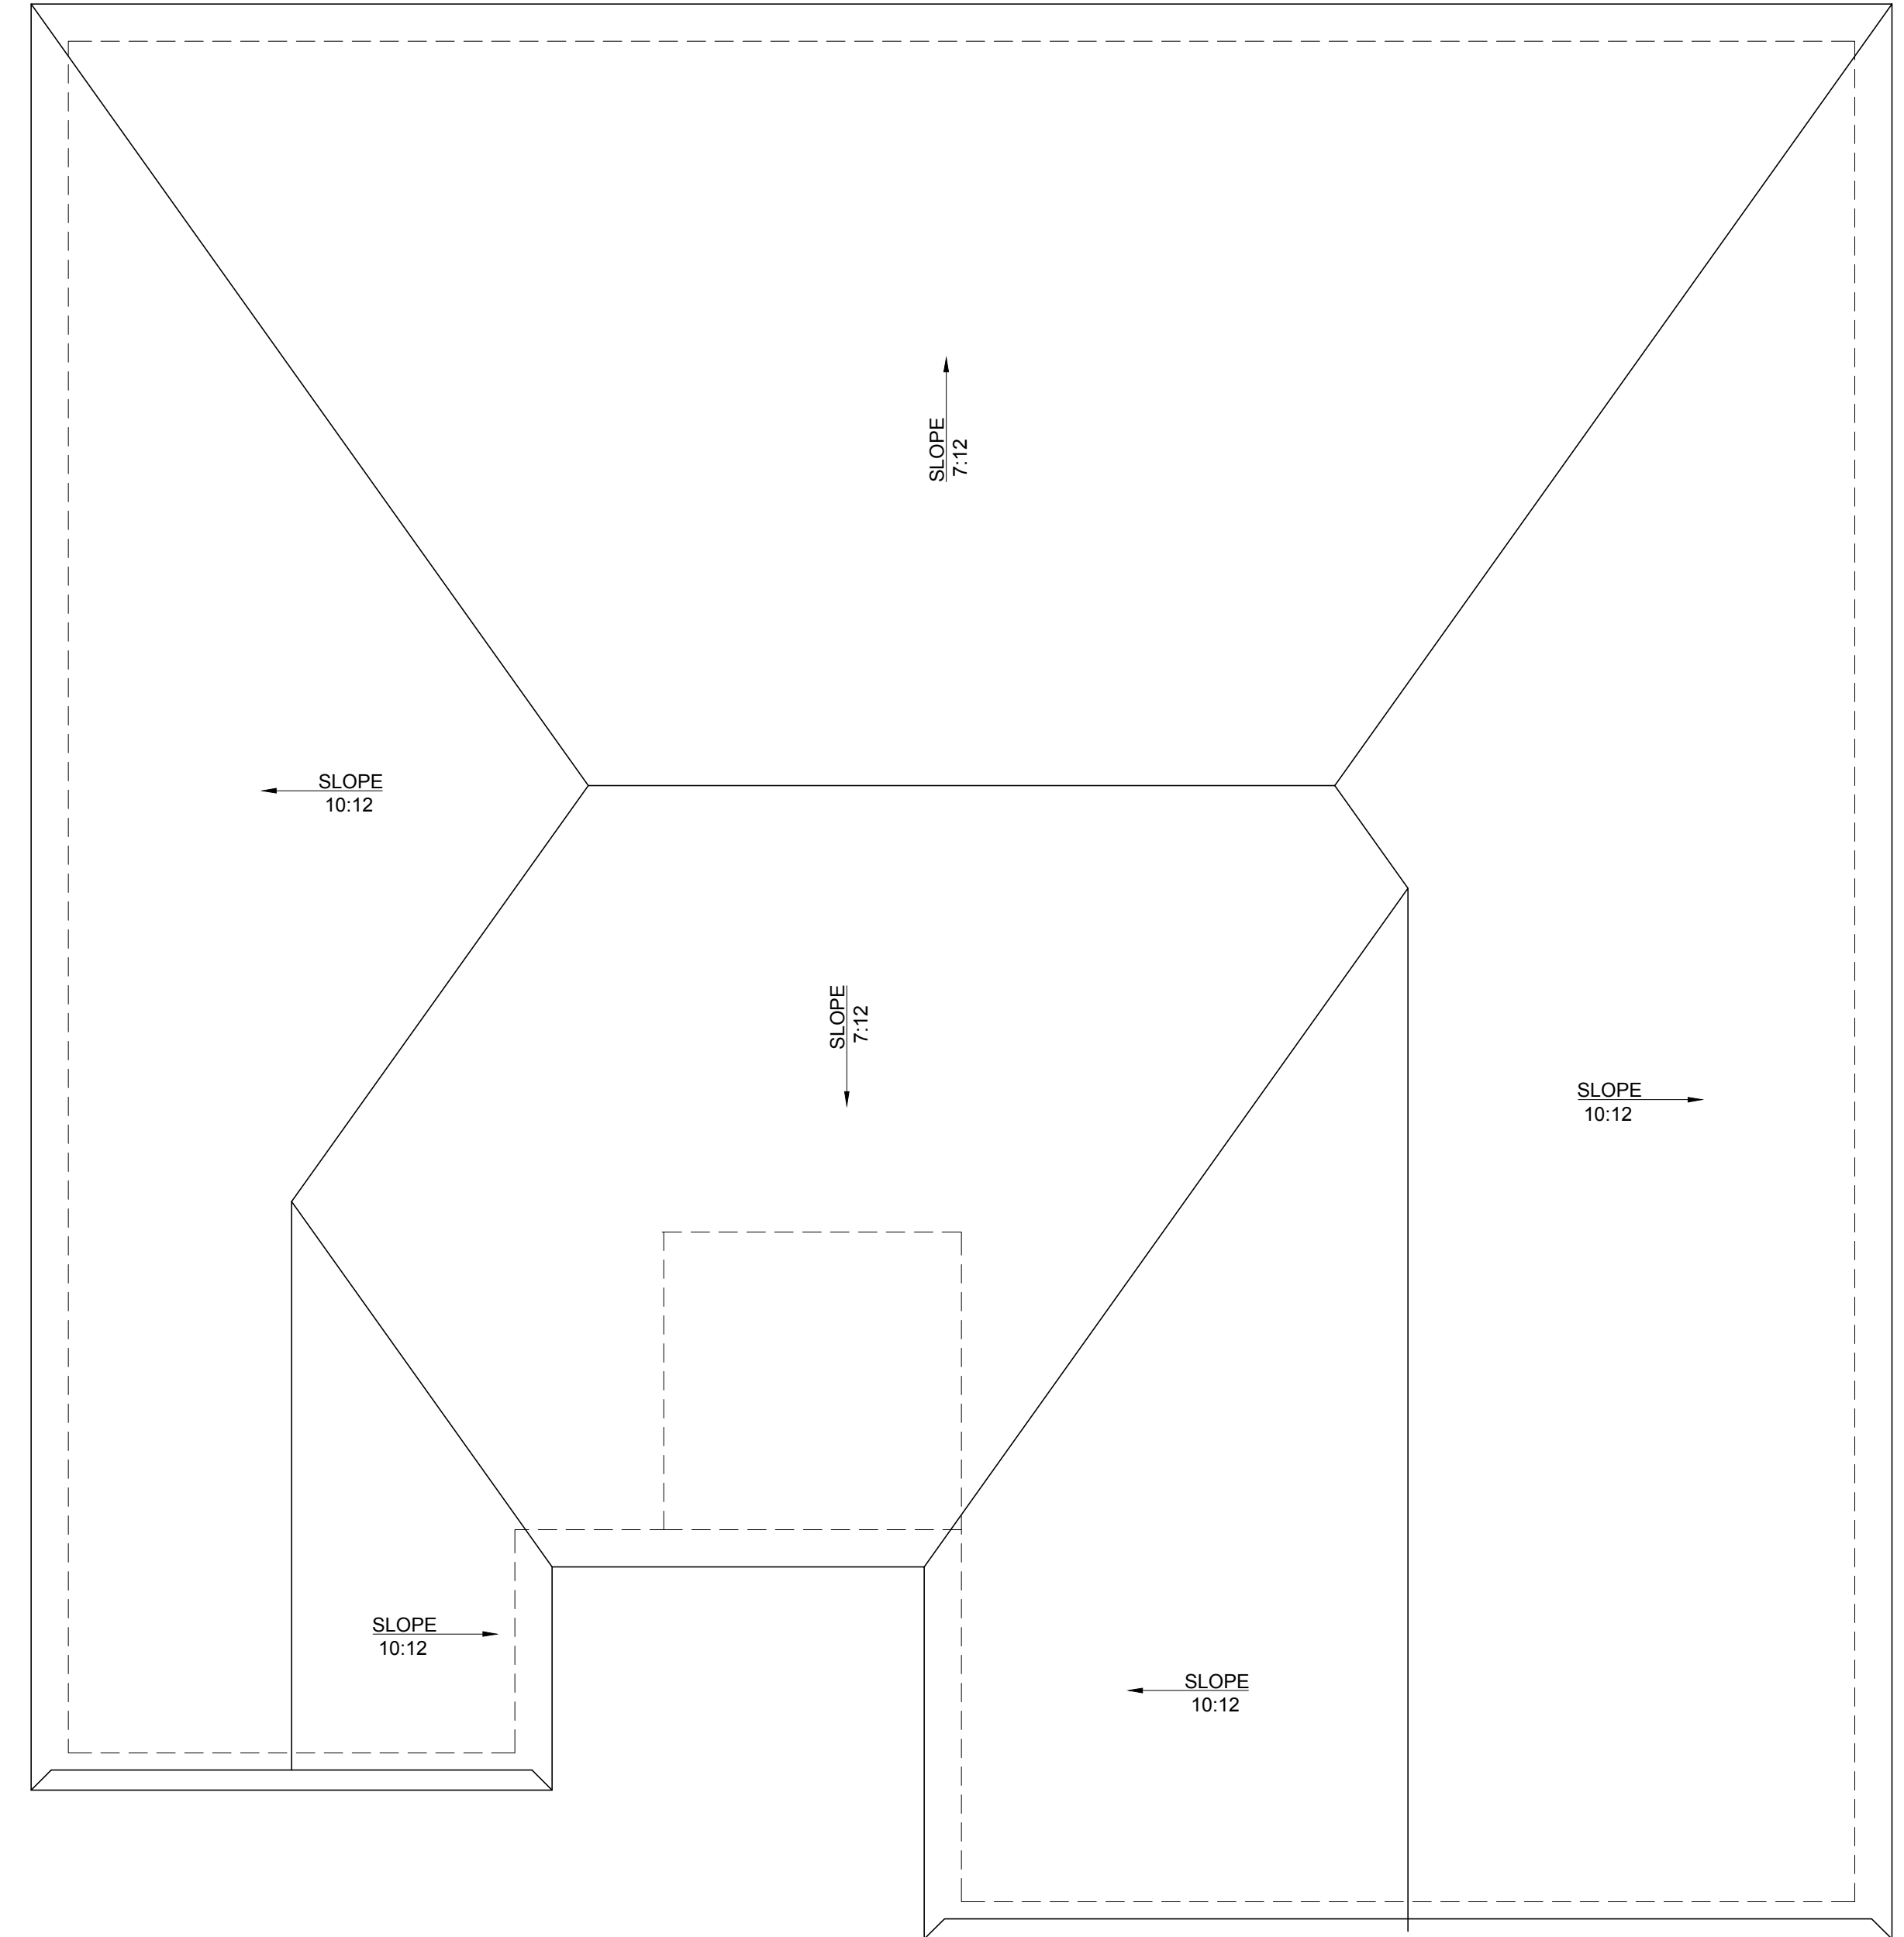

ROOF PLAN
SCALE: 1/4" = 1'-0"

ROOF NOTES:


- TRUSSES AS DESIGNED AND SPECIFIED BY TRUSS MANUFACTURER
- 2x6 ROOF RAFTERS 24" O.C. BRACED PER CODE
- GUTTER AND DOWNSPOUT LOCATIONS AS PER CONTRACTOR
- VERIFY HEEL HEIGHT W/ CONTRACTOR
- SIMPSON SEISMIC & HURRICANE TIES OR EQUAL TO PROVIDE A POSITIVE CONNECTION BETWEEN TRUSS/RAFTER AND THE WALL OF THE STRUCTURE TO RESIST WIND AND SEISMIC FORCES

HM LOT 25 SPEC
HILLSIDE MEADOW - LOT 25
5700 HILLSIDE TRAIL, NEWBURGH, IN 47630
ASPEN PLAN


Reinbrecht Homes

304 East State Road 68
Haubstadt, IN 47639
812-615-0137
www.reinbrechthomes.com

A3
4 of 4

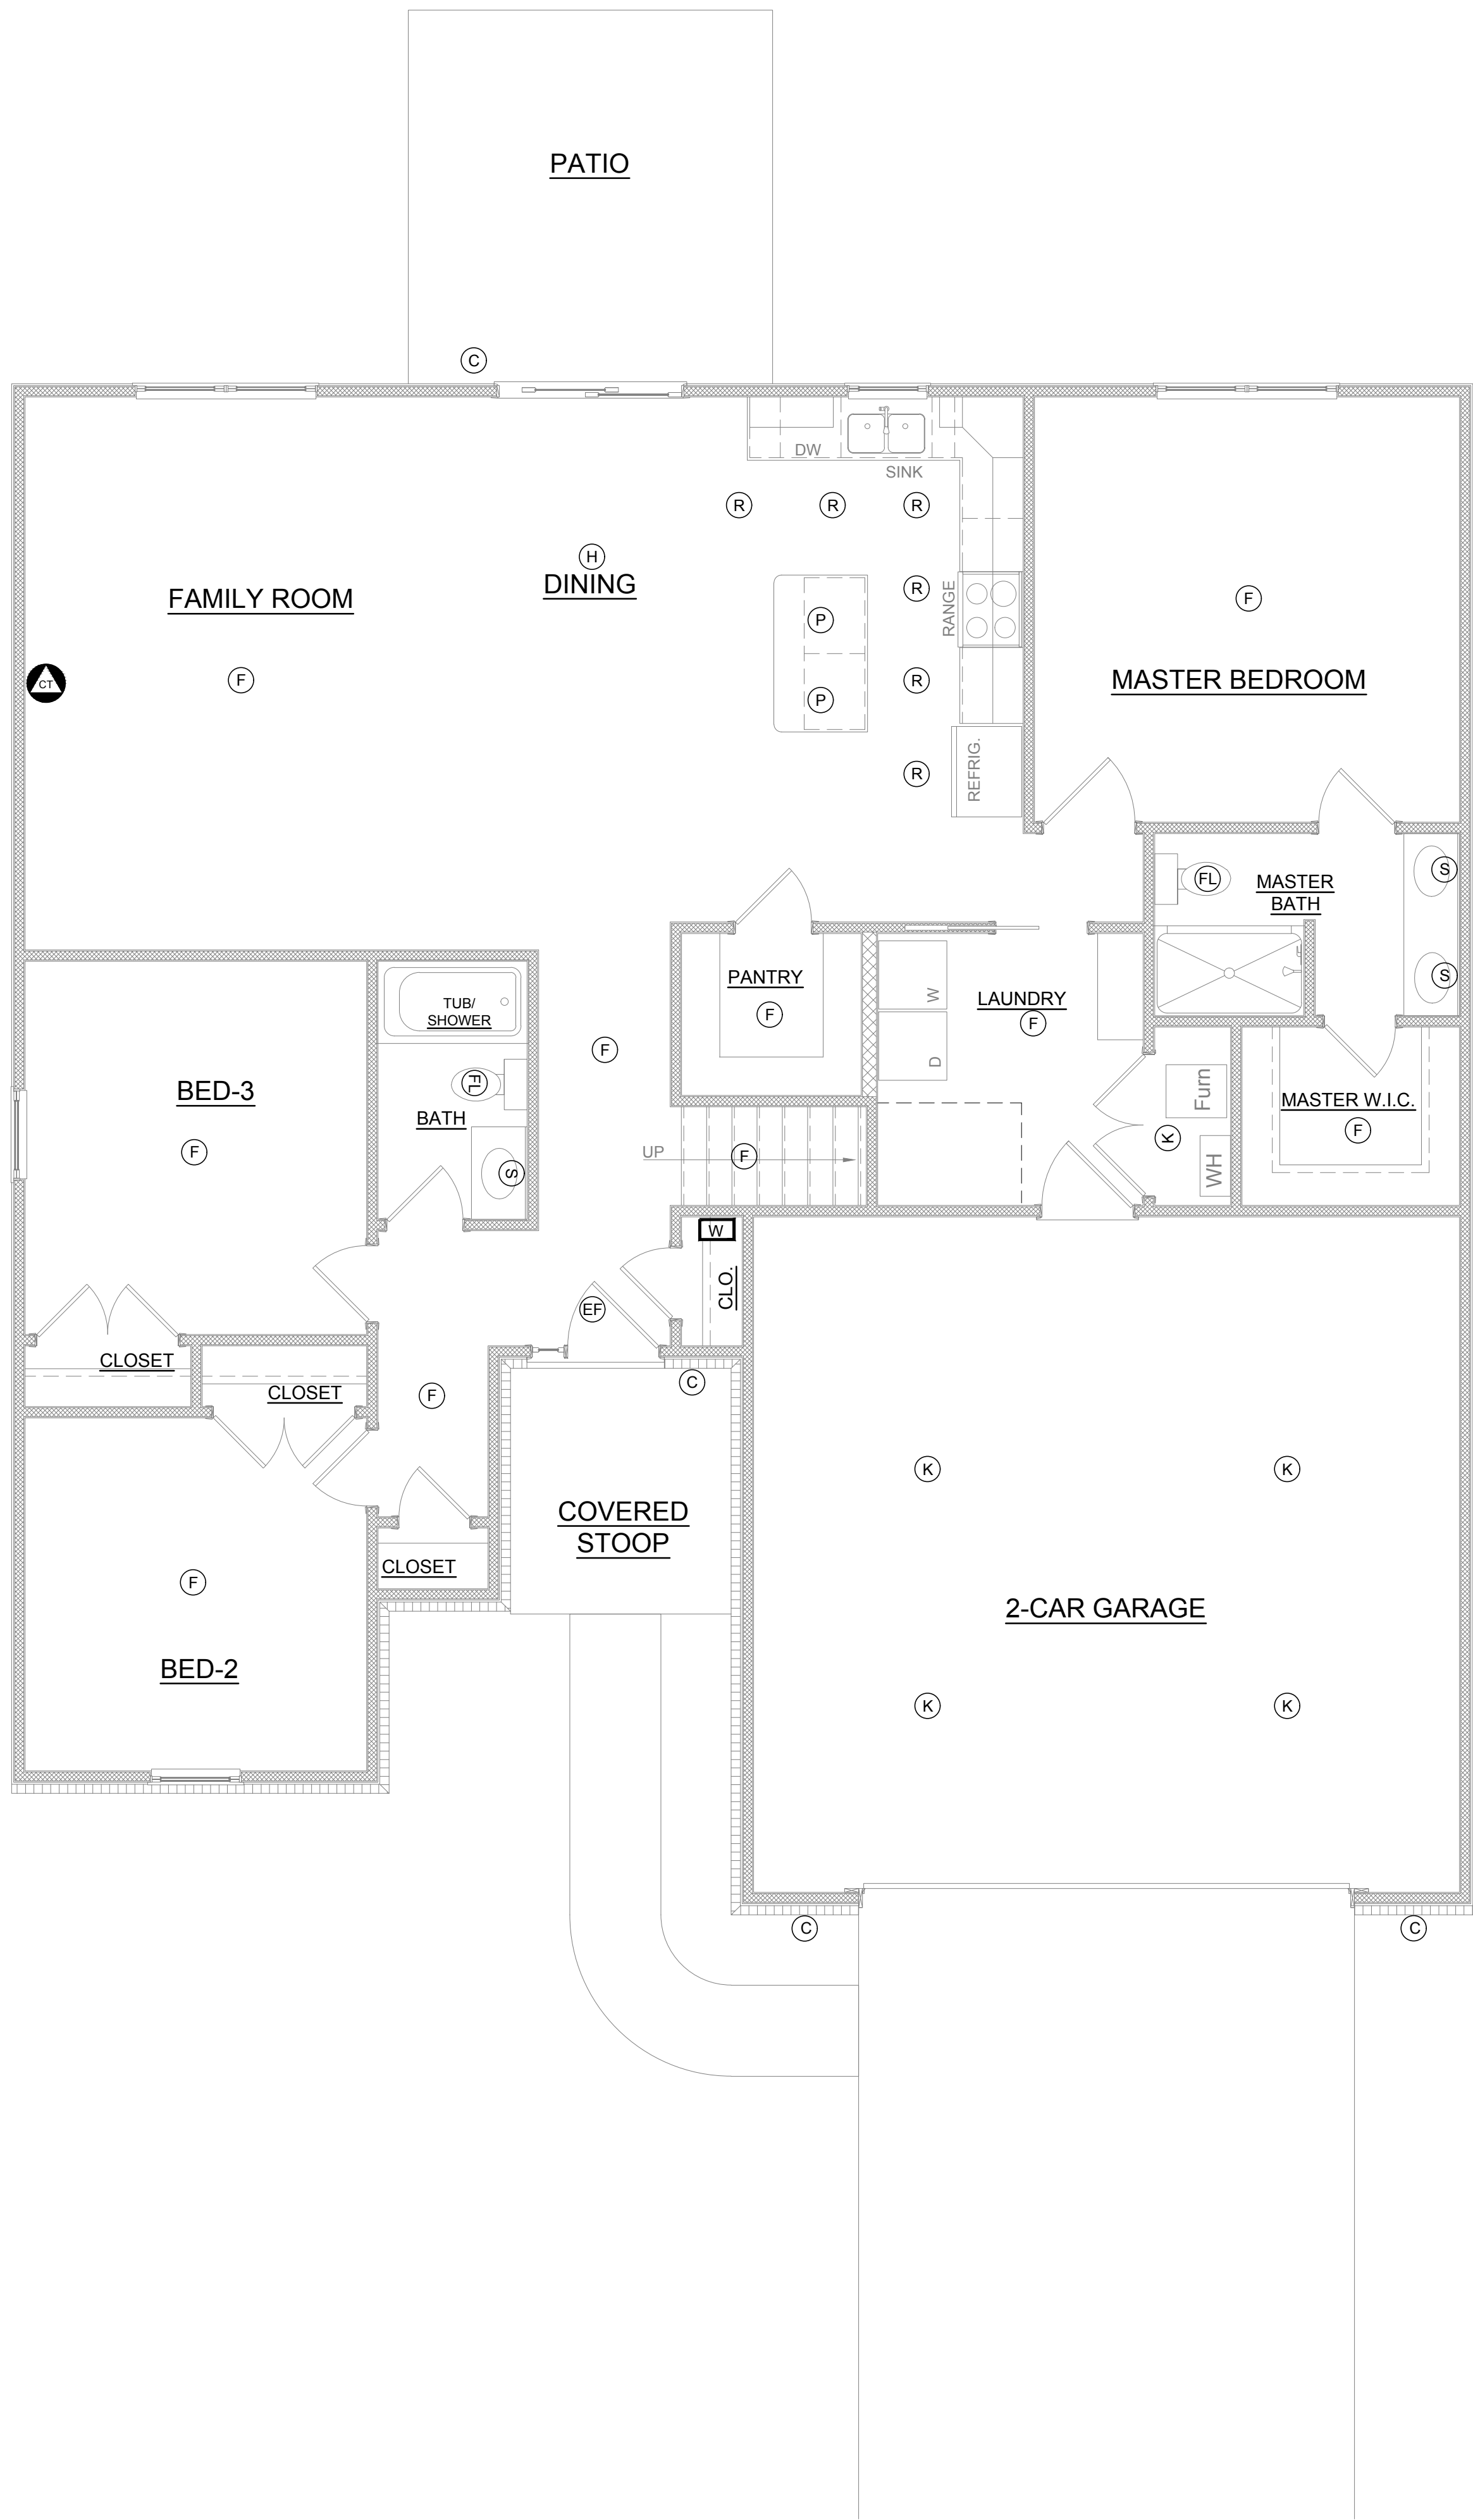

MAIN LEVEL ELECTRICAL PLAN
SCALE: 1/4" = 1'-0"

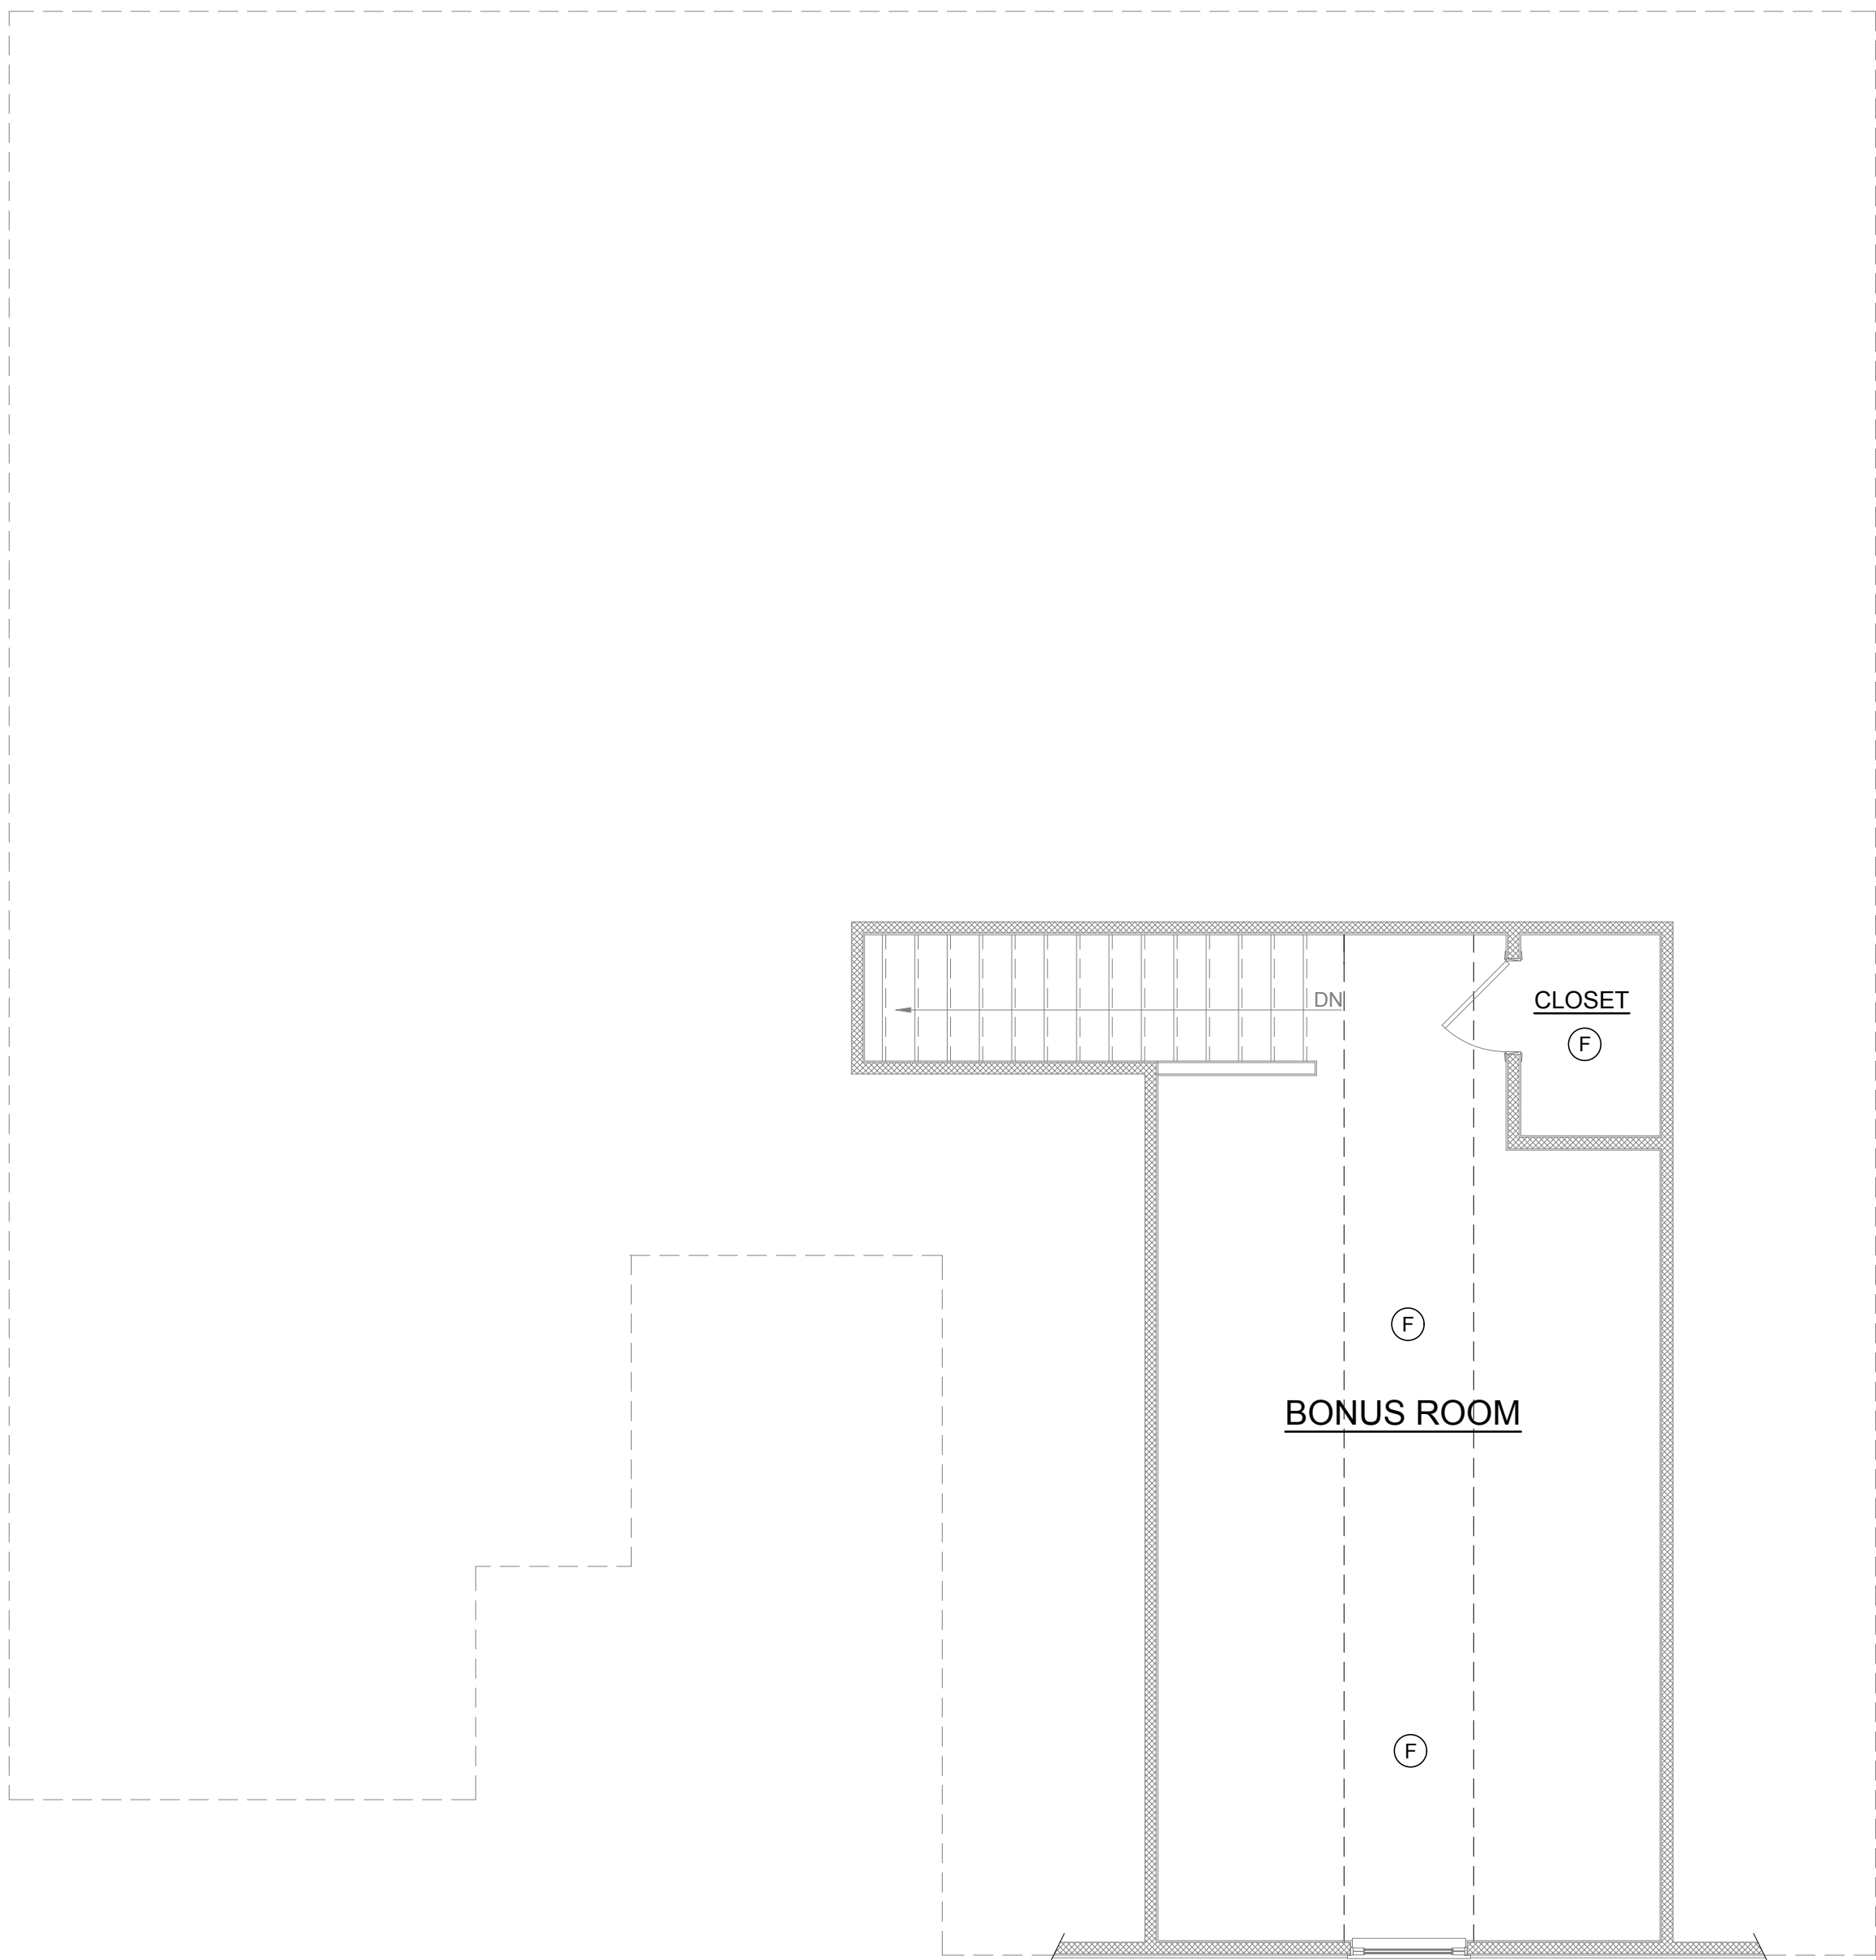

UPPER LEVEL ELECTRICAL PLAN
SCALE: 1/4" = 1'-0"

LIGHTING LEGEND:

- (P) PENDANT
- (H) HANGING CHANDELIER
- (EF) ENTRY FOYER
- (F) FLUSH MOUNT
- (R) RECESSED CAN
- (S) VANITY SCONCE
- (C) COACH SCONCE
- (SF) SEMI FLUSH
- (PT) POST LIGHT
- (FL) FLUORESCENT LIGHT
- (FLV) BATH FAN LIGHT
- (HLV) HEAT LIGHT VENT
- (BF) BATH FAN
- (K) KEYLESS
- (UC) UNDERCABINET
- (FC) CEILING FAN
- (PC) PULL CHAIN
- (HL) HEADER LIGHT CLOSET
- (FD) FLOOD LIGHT
- (FDM) FLOOD MOTION
- (WP) WALL PACK
- (STP) STEP LIGHT
- (DB) DOOR BELL

LOW VOLTAGE LEGEND:

- (W) CENTRAL HUB
- (CA) CAT6/ CABLE DROP

HM LOT 25 SPEC
HILLSIDE MEADOW - LOT 25
5700 HILLSIDE TRAIL; NEWBURGH, IN 47630
ASPEN PLAN




304 East State Road 68
Haustadt, IN 47639
812-615-0137
www.reinbrechthomes.com

FLOORING LEGEND:

MATERIALS KEY:

- CARPET
- GLUE DOWN LVT
- CLICK LVT
- GROUTED LVT
- CERAMIC TILE
- CONCRETE
- OTHER

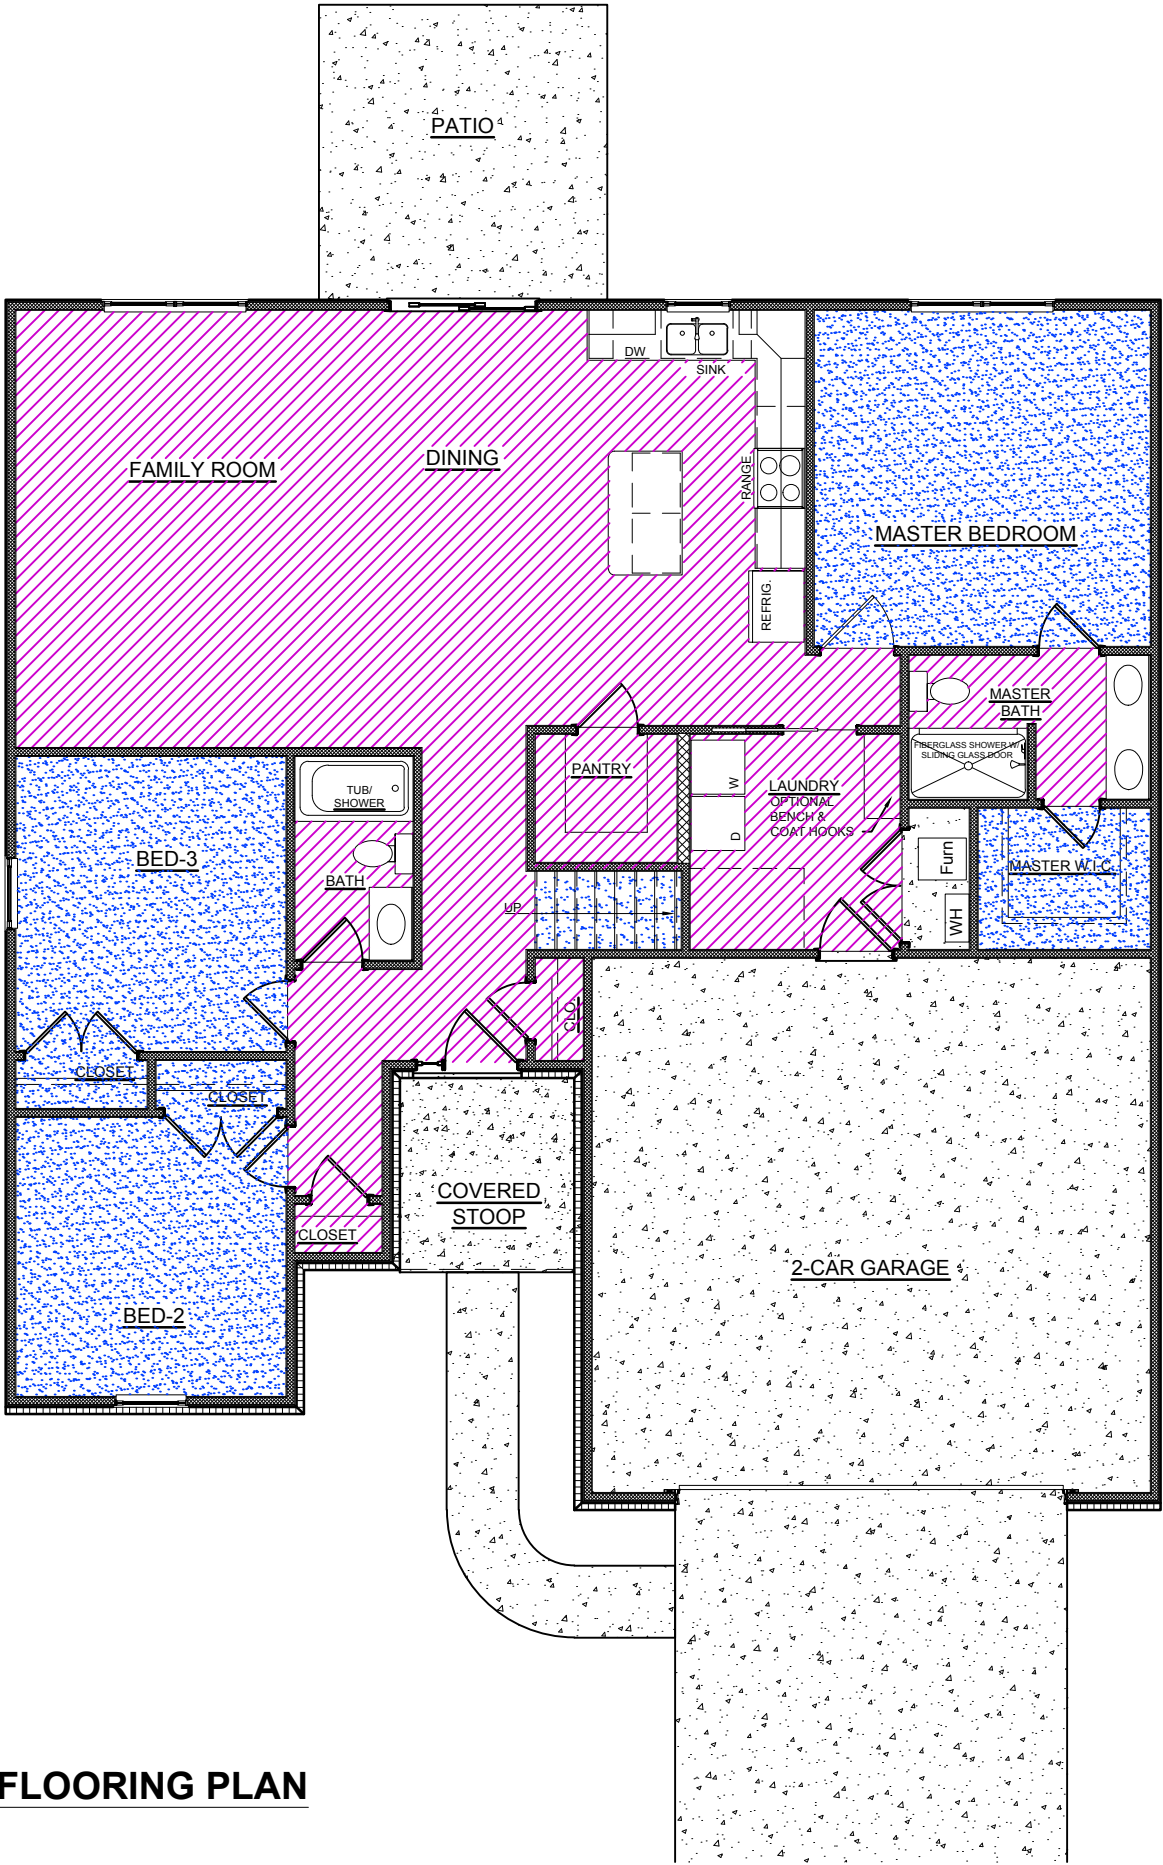

MAIN LEVEL FLOORING PLAN
NO SCALE

HM LOT 25 SPEC
HILLSIDE MEADOW - LOT 25
5700 HILLSIDE TRAIL; NEWBURGH, IN 47630
ASPEN PLAN


FL1



FLOORING LEGEND:

MATERIALS KEY:

- CARPET
- GLUE DOWN LVT
- CLICK LVT
- GROUTED LVT
- CERAMIC TILE
- CONCRETE
- OTHER

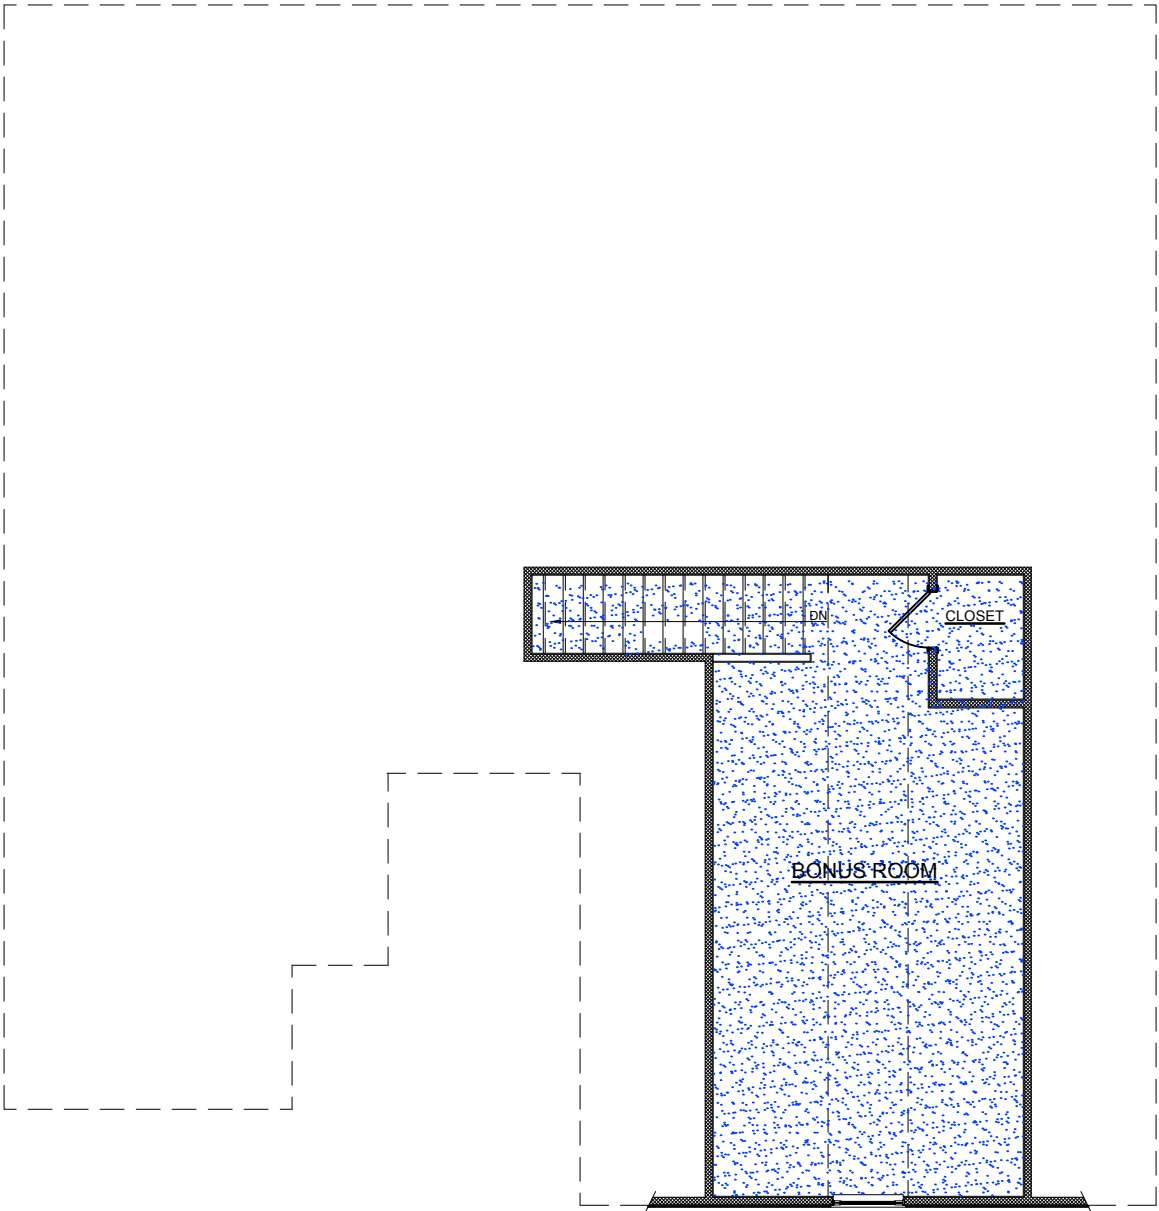

HM LOT 25 SPEC
HILLSIDE MEADOW - LOT 25
5700 HILLSIDE TRAIL; NEWBURGH, IN 47630
ASPEN PLAN

UPPER LEVEL FLOORING PLAN
NO SCALE

